

SkLO

STAND DESIGN

JANUARY 2019 MAISON&OBJET PARIS

-TENDER-

DRAWING INDEX

T0.0	TITLE SHEET
A1.0	PLANS
A1.1	PLANS
A1.2	ELEVATIONS
A1.3	ELEVATIONS
A1.4	ELEVATIONS
A1.5	ELEVATIONS
A1.6	SECTION
A2.0	ELECTRICAL PLAN
A2.1	ELECTRICAL / LIGHTING LAYOUT
A2.2	ELECTRICAL / LIGHTING LAYOUT
A2.3	ELECTRICAL / LIGHTING LAYOUT
A2.4	ELECTRICAL / LIGHTING LAYOUT
A3.0	PAINTING PLAN
A3.1	PAINTING ELEVATION
A3.2	PAINTING ELEVATION
A3.3	PAINTING ELEVATION

SkLO



SkLO

95 WEST MATHESON STREET
HEALDSBURG CALIFORNIA 95448
CONTACT: PAUL PAVLAK
EMAIL: PAUL@SKLO.COM
TEL: 707.433.8797

STAND DESIGN
JAN 2019 MAISON&OBJET
-TENDER-

DATE ISSUED	09.27.2018
JOB NUMBER	-
FILENAME	-
SCALE	-

T0.0

TITLE SHEET

SkLO



SkLO


95 WEST MATHESON STREET
HEALDSBURG CALIFORNIA 95448
CONTACT: PAUL PAVLAK
EMAIL: PAUL@SKLO.COM
TEL: 707.433.8797

STAND DESIGN
JAN 2019 MAISON&OBJET
-TENDER-

DATE ISSUED	09.27.2018
JOB NUMBER	-
FILENAME	-
SCALE	NOT TO SCALE

A1.0

PLANS

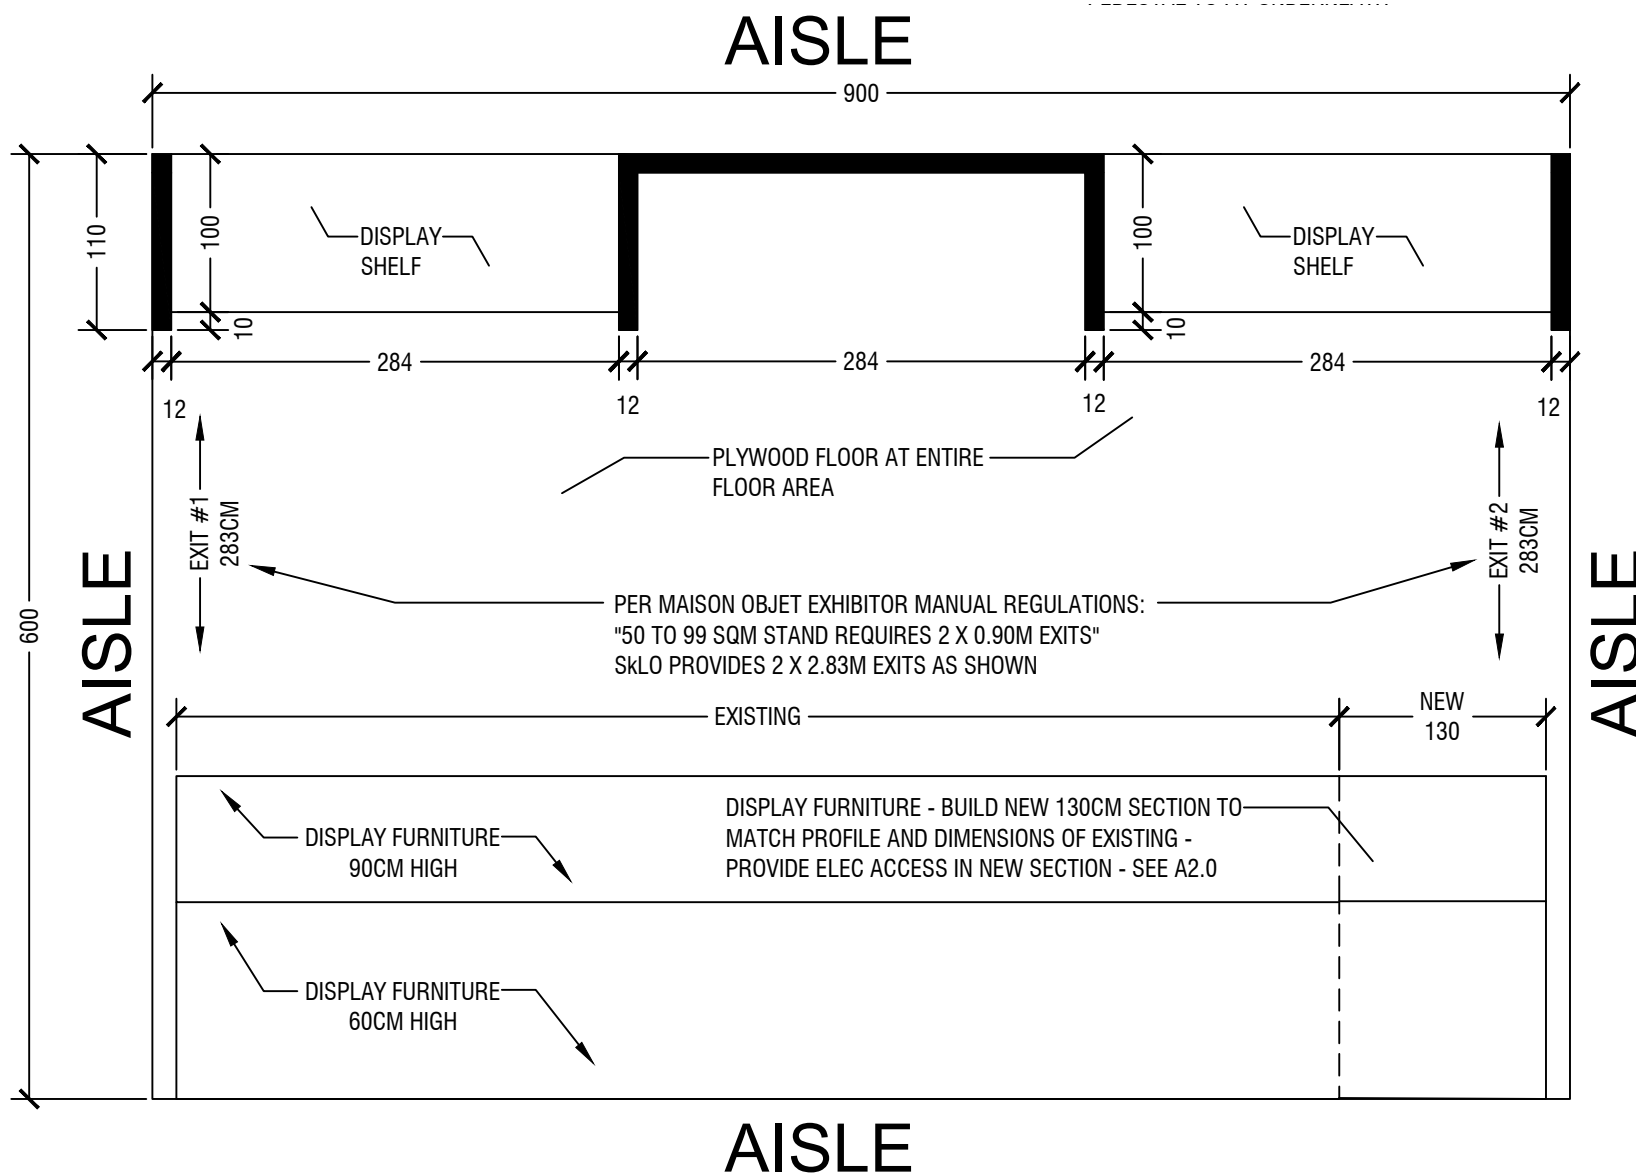

1 FLOOR PLAN

SkLO



SkLO

95 WEST MATHESON STREET
HEALDSBURG CALIFORNIA 95448
CONTACT: PAUL PAVLAK
EMAIL: PAUL@SKLO.COM
TEL: 707.433.8797

STAND DESIGN
JAN 2019 MAISON&OBJET
-TENDER-

DATE ISSUED 09.27.2018


JOB NUMBER -

FILENAME -

SCALE NOT TO SCALE

A1.1

PLANS

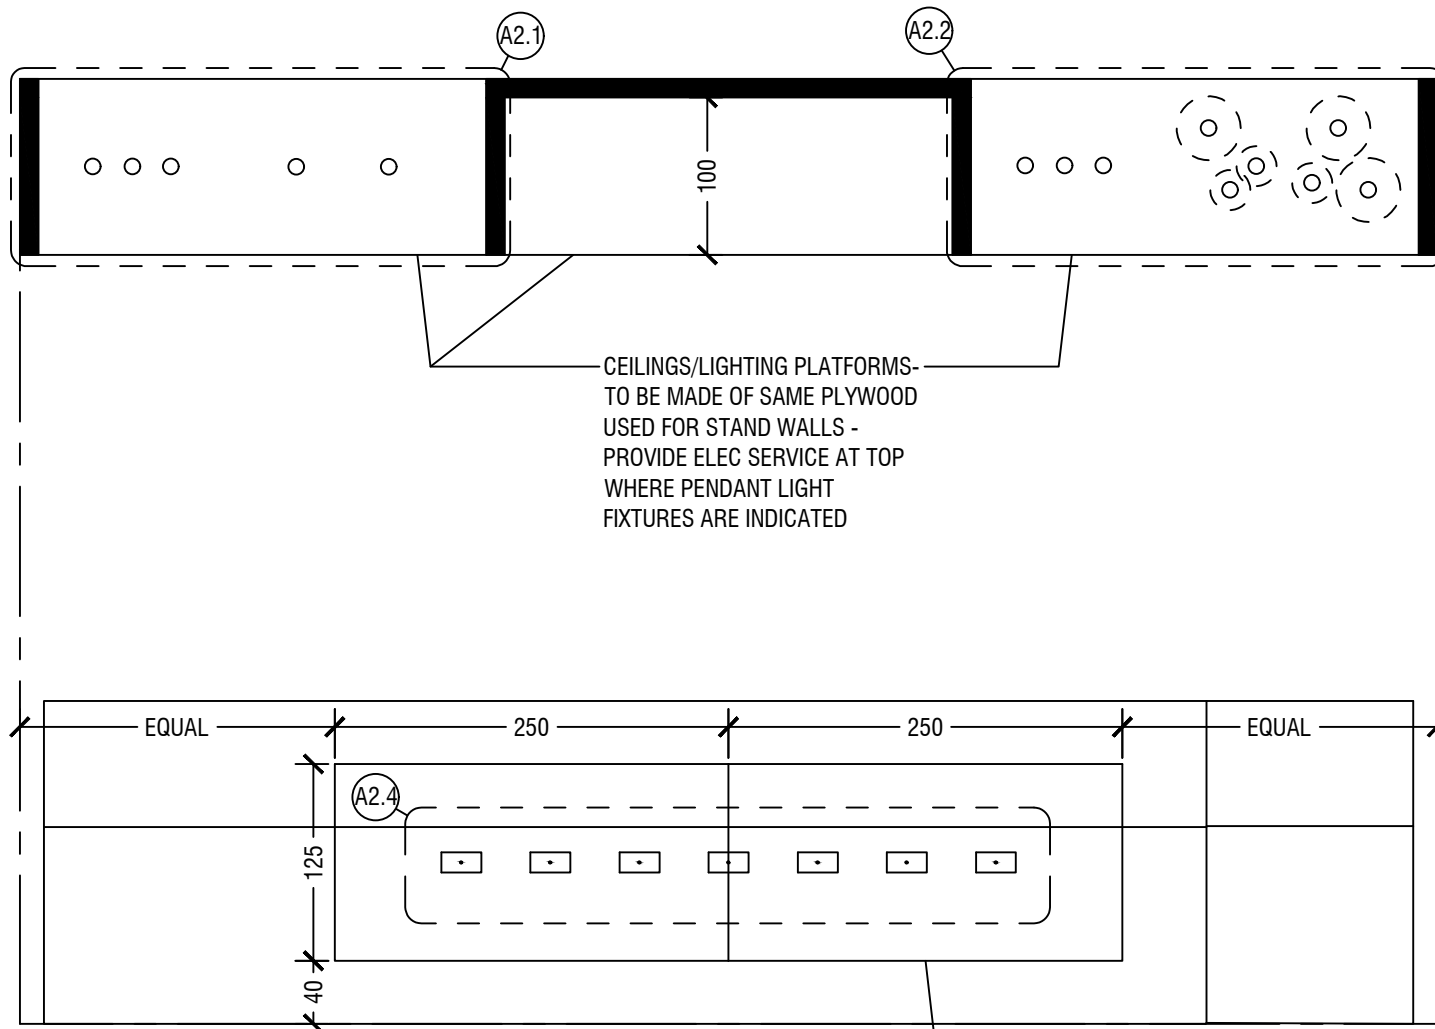

1 REFLECTED CEILING PLAN


SkLO



SkLO

95 WEST MATHESON STREET
HEALDSBURG CALIFORNIA 95448
CONTACT: PAUL PAVLAK
EMAIL: PAUL@SKLO.COM
TEL: 707.433.8797

STAND DESIGN
JAN 2019 MAISON&OBJET
-TENDER-

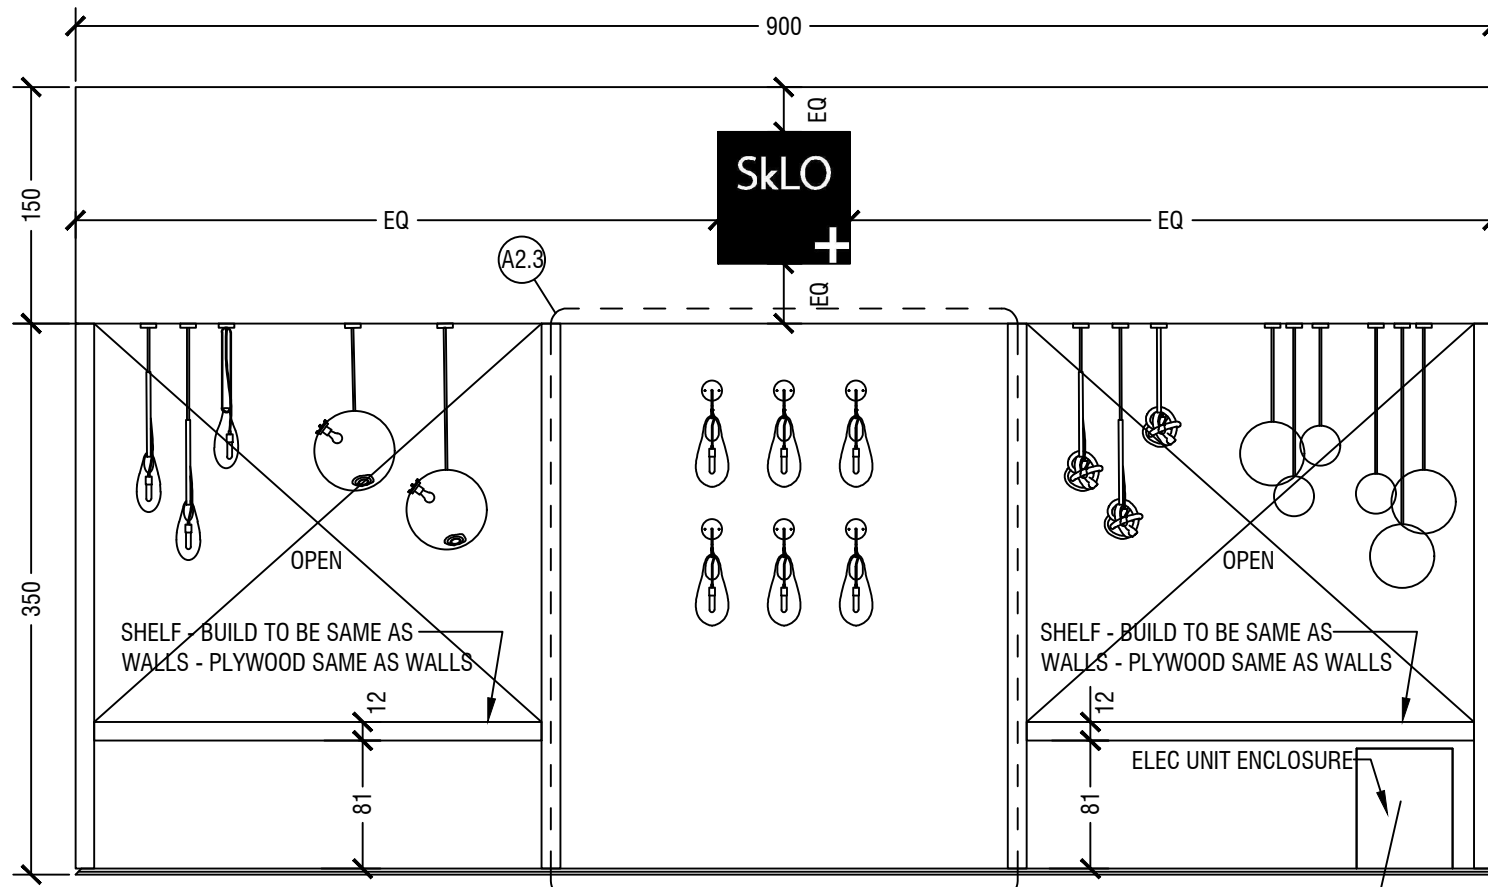

① REAR WALL ELEVATION

USE WHITE PEDESTAL TO COVER
ELECTRICAL SERVICE UNIT -
PROVIDED BY SKLO - VERIFY THAT
SHELF IS HIGH ENOUGH FOR
PEDESTAL TO FIT UNDERNEATH

DATE ISSUED	09.27.2018
JOB NUMBER	-
FILENAME	-
SCALE	NOT TO SCALE

A1.2

ELEVATIONS

SkLO



SkLO


95 WEST MATHESON STREET
HEALDSBURG CALIFORNIA 95448
CONTACT: PAUL PAVLAK
EMAIL: PAUL@SKLO.COM
TEL: 707.433.8797

STAND DESIGN
JAN 2019 MAISON&OBJET
-TENDER-

DATE ISSUED	09.27.2018
JOB NUMBER	-
FILENAME	-
SCALE	NOT TO SCALE

A1.3

ELEVATIONS

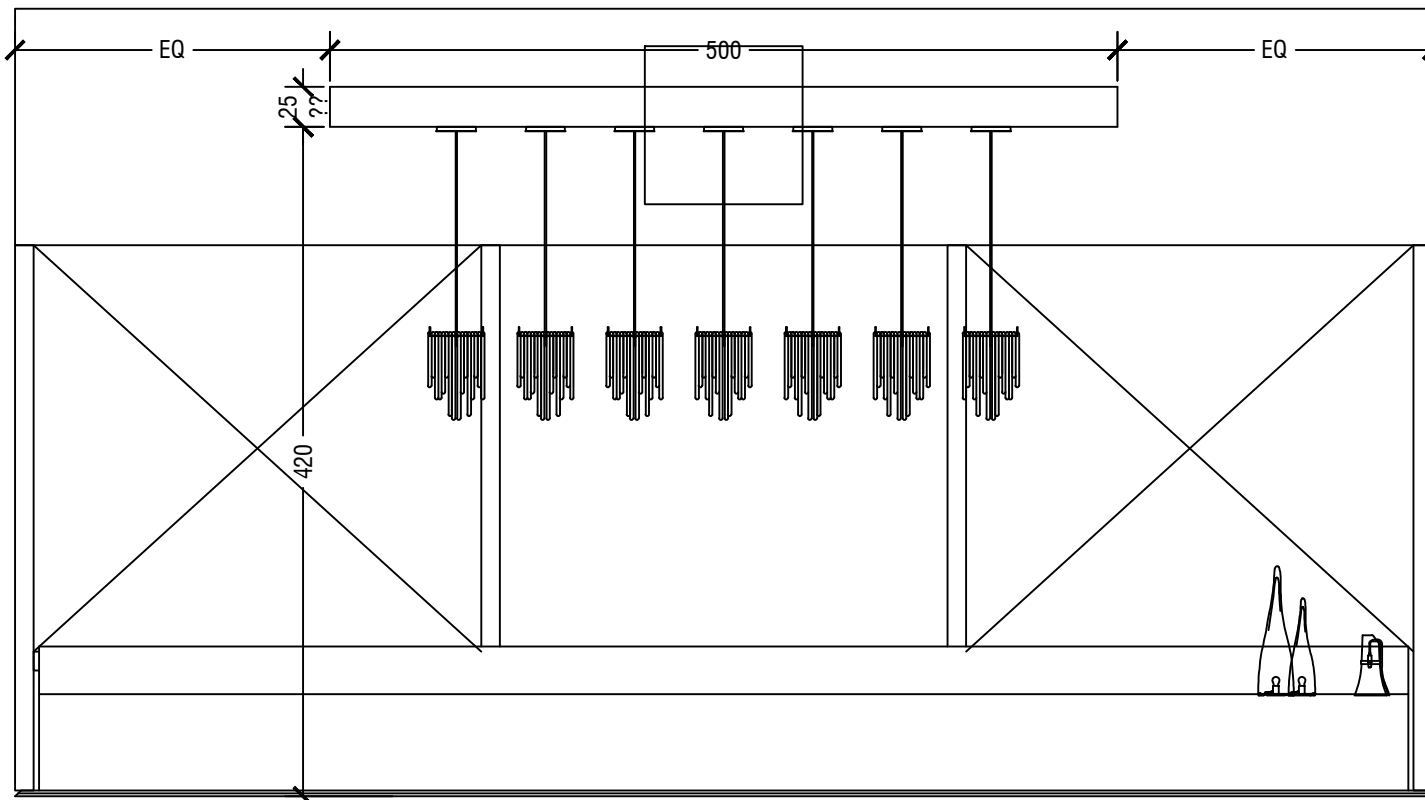

1 FRONT AISLE / LIGHTING SUSPENSION ELEVATION


SkLO



SkLO

95 WEST MATHESON STREET
HEALDSBURG CALIFORNIA 95448
CONTACT: PAUL PAVLAK
EMAIL: PAUL@SKLO.COM
TEL: 707.433.8797

STAND DESIGN
JAN 2019 MAISON&OBJET
-TENDER-

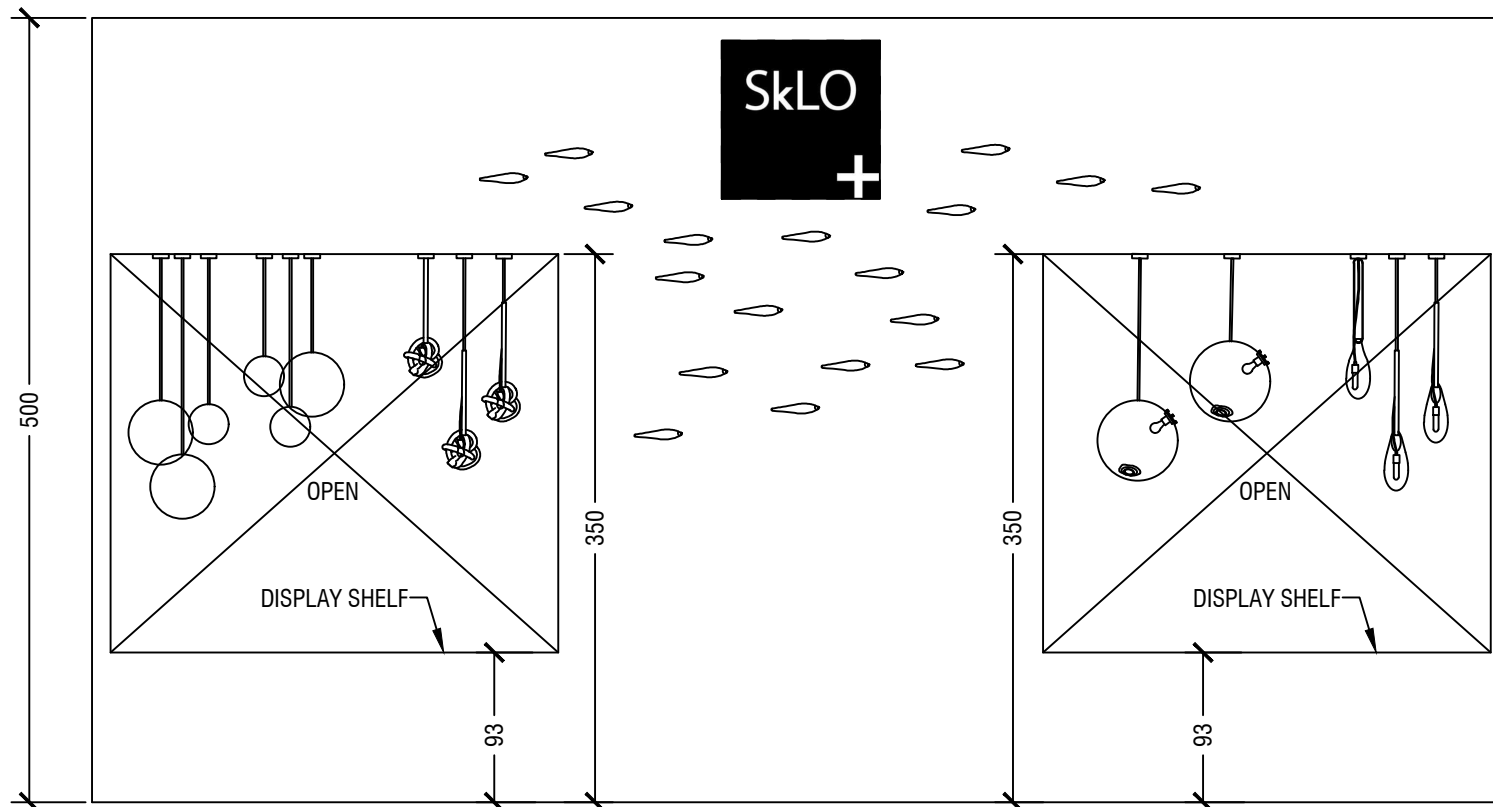


① REAR WALL - BACK SIDE ELEVATION

DATE ISSUED	09.27.2018
JOB NUMBER	-
FILENAME	-
SCALE	NOT TO SCALE

A1.4

ELEVATIONS

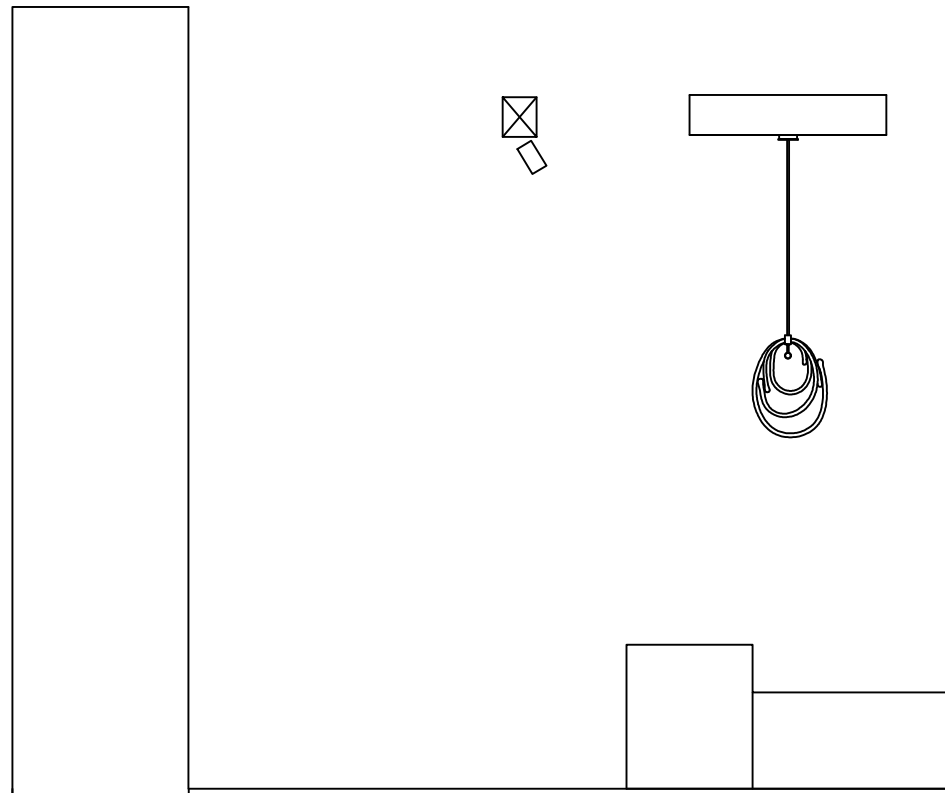

① SIDE AISLE ELEVATION

SkLO



SkLO

95 WEST MATHESON STREET
HEALDSBURG CALIFORNIA 95448
CONTACT: PAUL PAVLAK
EMAIL: PAUL@SKLO.COM
TEL: 707.433.8797

STAND DESIGN
JAN 2019 MAISON&OBJET
-TENDER-

DATE ISSUED	09.27.2018
JOB NUMBER	-
FILENAME	-
SCALE	NOT TO SCALE

A1.5

ELEVATIONS

SkLO



SkLO


95 WEST MATHESON STREET
HEALDSBURG CALIFORNIA 95448
CONTACT: PAUL PAVLAK
EMAIL: PAUL@SKLO.COM
TEL: 707.433.8797

STAND DESIGN
JAN 2019 MAISON&OBJET
-TENDER-

DATE ISSUED	09.27.2018
JOB NUMBER	-
FILENAME	-
SCALE	NOT TO SCALE

A1.6

SECTION/ELEVATION

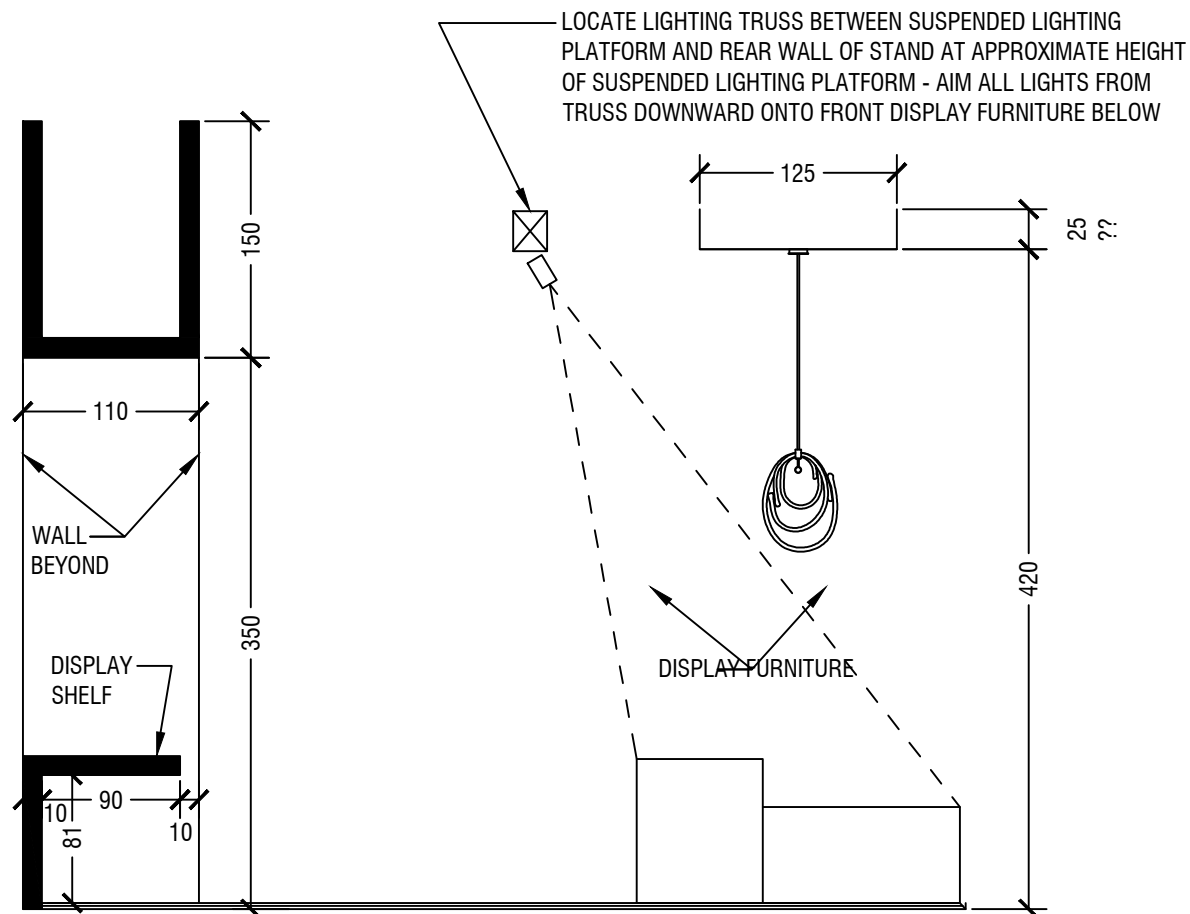

1 SECTION THRU STAND

SkLO



SkLO


95 WEST MATHESON STREET
HEALDSBURG CALIFORNIA 95448
CONTACT: PAUL PAVLAK
EMAIL: PAUL@SKLO.COM
TEL: 707.433.8797

STAND DESIGN
JAN 2019 MAISON&OBJET
-TENDER-

DATE ISSUED	09.27.2018
JOB NUMBER	-
FILENAME	-
SCALE	NOT TO SCALE

A2.0

ELECTRICAL

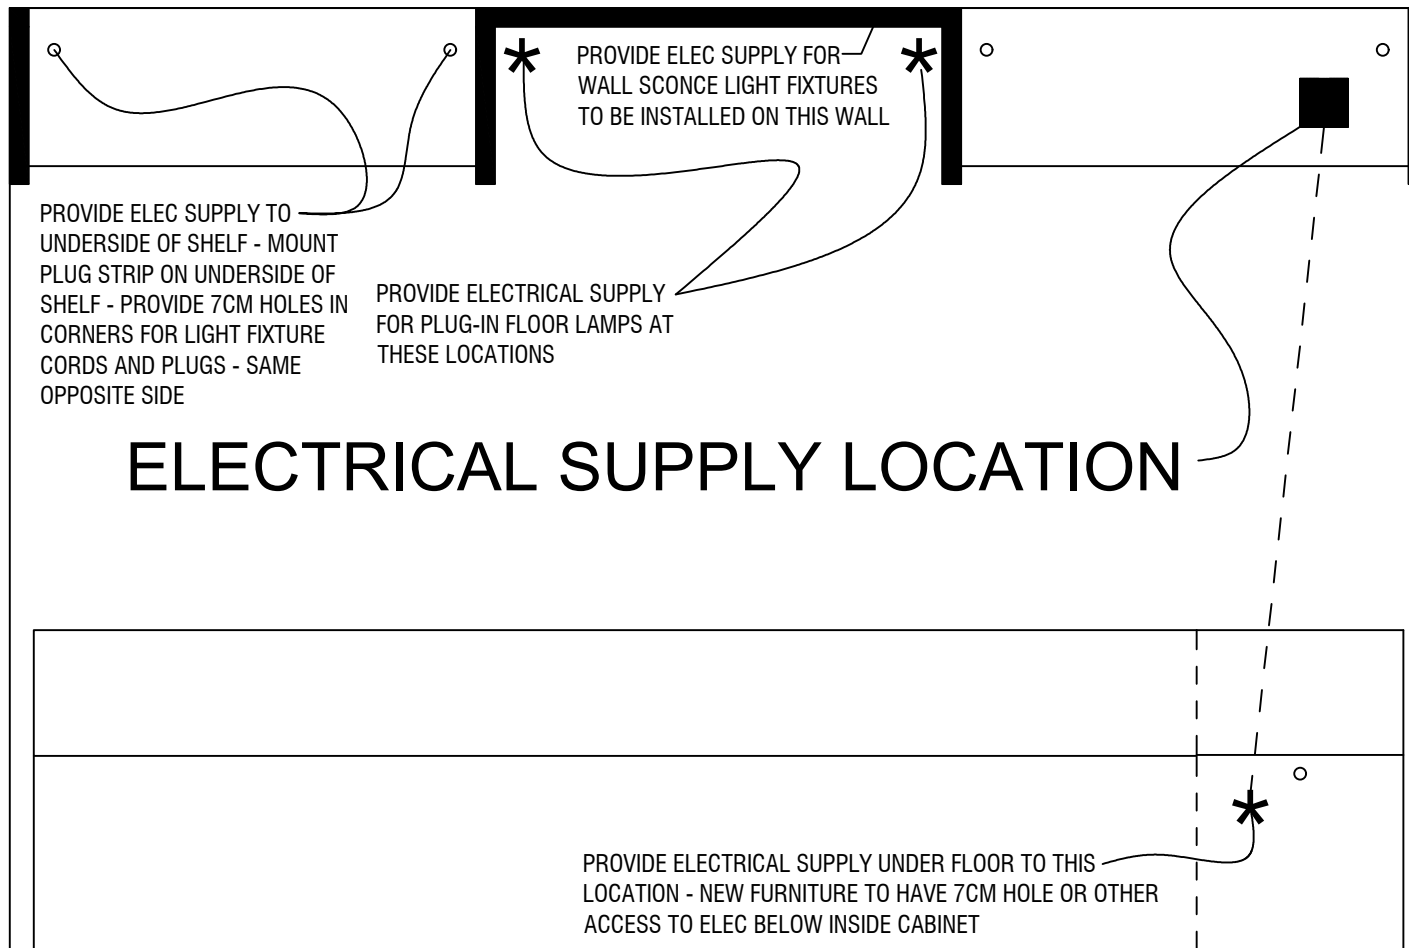

① ELECTRICAL PLAN

SkLO



SkLO


95 WEST MATHESON STREET
HEALDSBURG CALIFORNIA 95448
CONTACT: PAUL PAVLAK
EMAIL: PAUL@SKLO.COM
TEL: 707.433.8797

STAND DESIGN
JAN 2019 MAISON&OBJET
-TENDER-

DATE ISSUED	09.27.2018
JOB NUMBER	-
FILENAME	-
SCALE	NOT TO SCALE

A2.1

ELECTRICAL

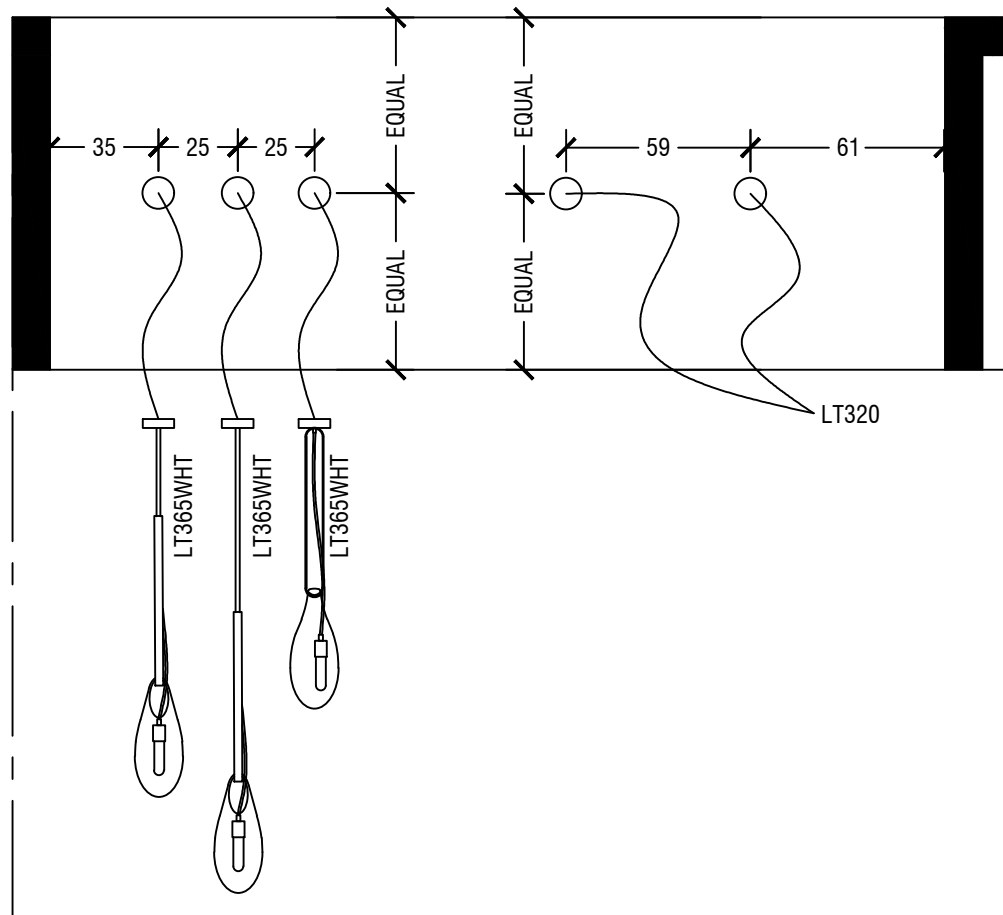


1 PENDANT LIGHTING LAYOUT

SkLO

95 WEST MATHESON STREET
HEALDSBURG CALIFORNIA 95448
CONTACT: PAUL PAVLAK
EMAIL: PAUL@SKLO.COM
TEL: 707.433.8797

STAND DESIGN
JAN 2019 MAISON&OBJET
-TENDER-

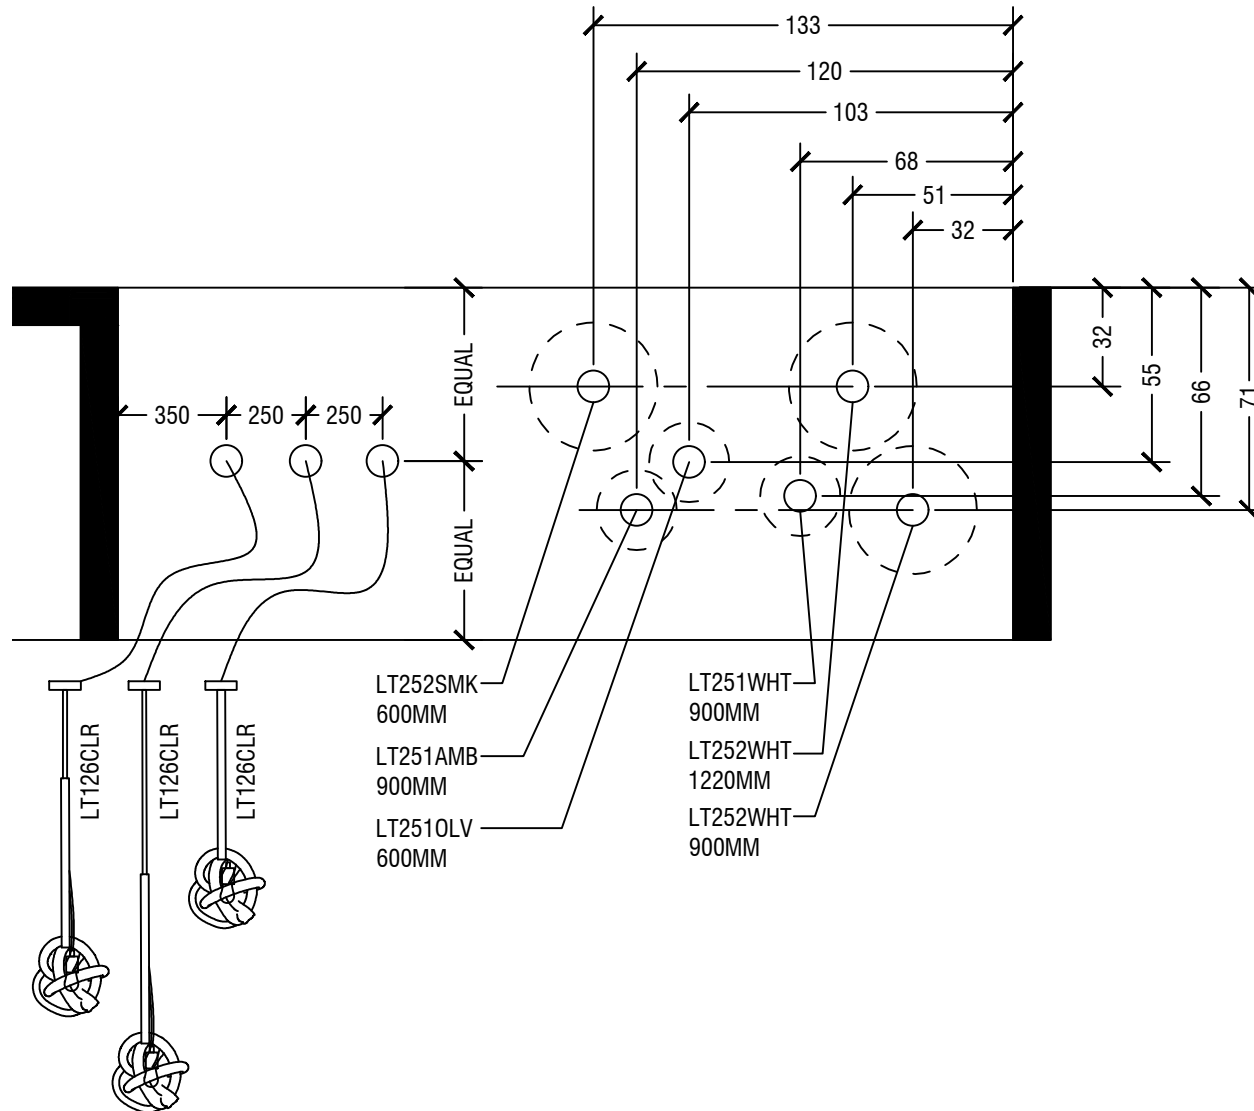

1 PENDANT LIGHTING LAYOUT

DATE ISSUED	09.27.2018
JOB NUMBER	-
FILENAME	-
SCALE	NOT TO SCALE

A2.2

SkLO



SkLO


95 WEST MATHESON STREET
HEALDSBURG CALIFORNIA 95448
CONTACT: PAUL PAVLAK
EMAIL: PAUL@SKLO.COM
TEL: 707.433.8797

STAND DESIGN
JAN 2019 MAISON&OBJET
-TENDER-

DATE ISSUED	09.27.2018
JOB NUMBER	-
FILENAME	-
SCALE	NOT TO SCALE

A2.3

ELECTRICAL

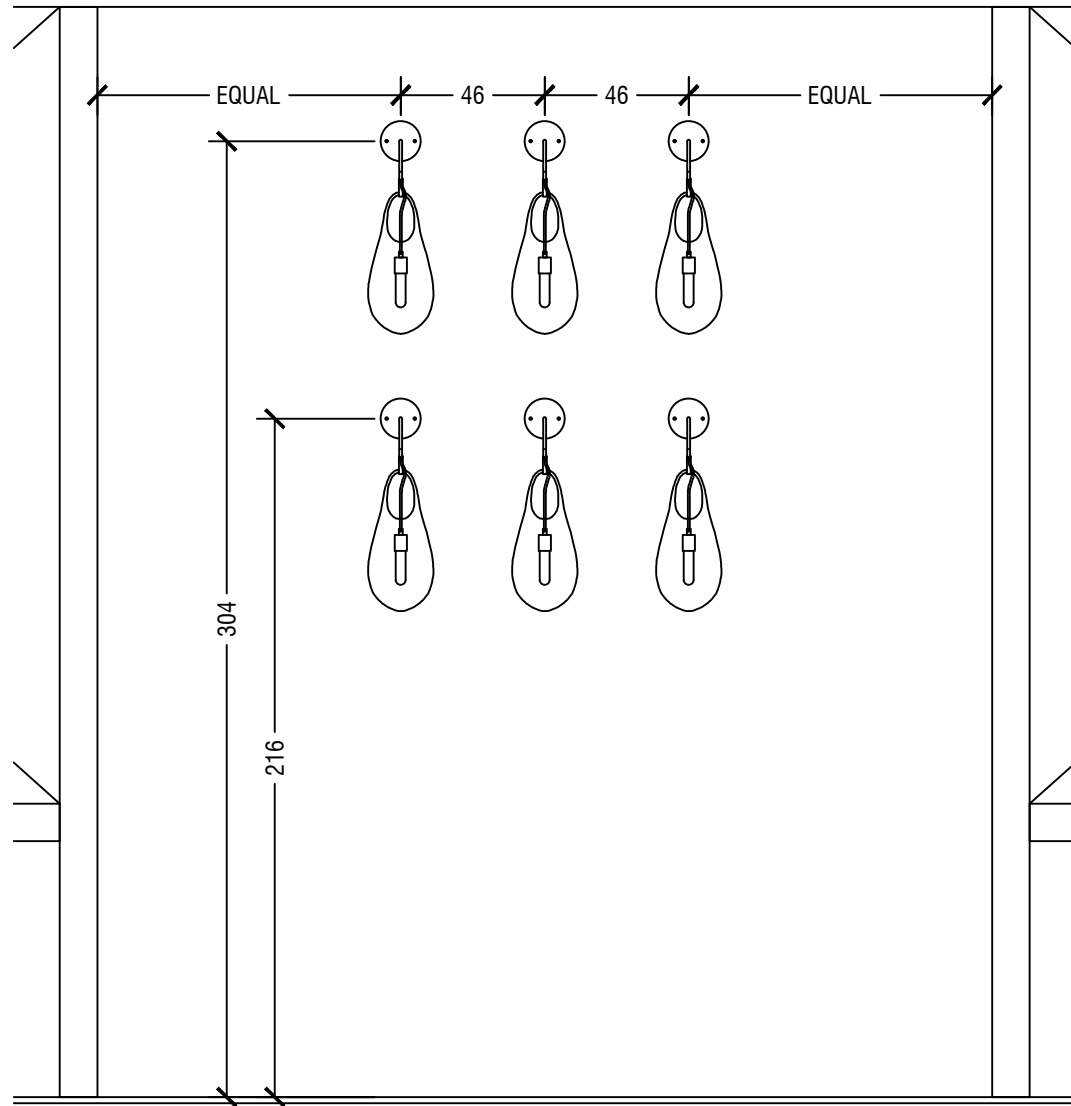

① WALL SCNCE LIGHTING LAYOUT


SkLO



SkLO

95 WEST MATHESON STREET
HEALDSBURG CALIFORNIA 95448
CONTACT: PAUL PAVLAK
EMAIL: PAUL@SKLO.COM
TEL: 707.433.8797

STAND DESIGN
JAN 2019 MAISON&OBJET
-TENDER-

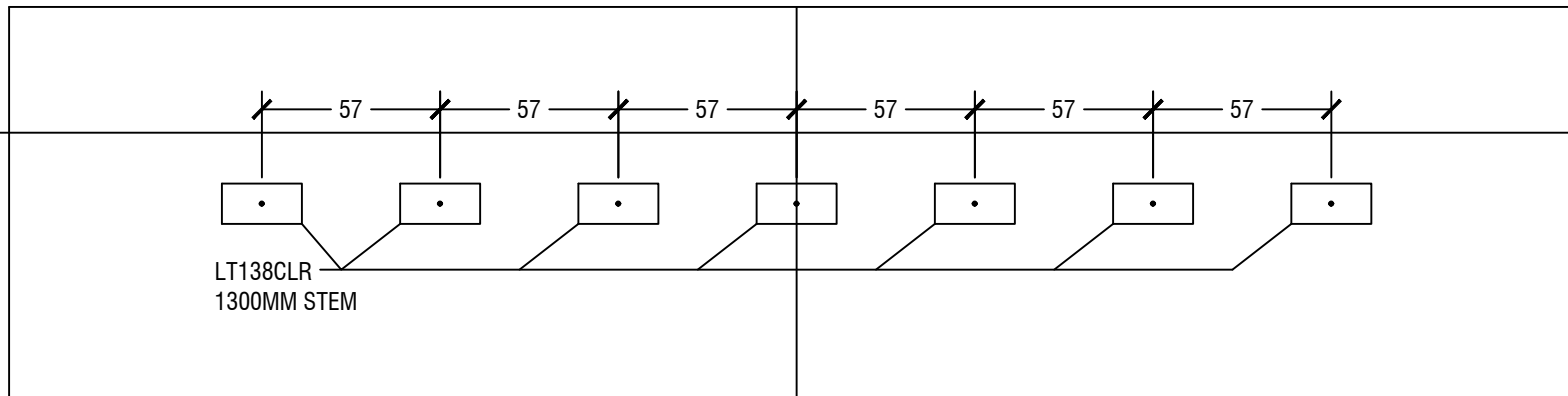


① SUSPENDED LIGHTING CLOUD - PENDANT LIGHTING LAYOUT

DATE ISSUED	09.27.2018
JOB NUMBER	-
FILENAME	-
SCALE	NOT TO SCALE

A2.4

ELECTRICAL

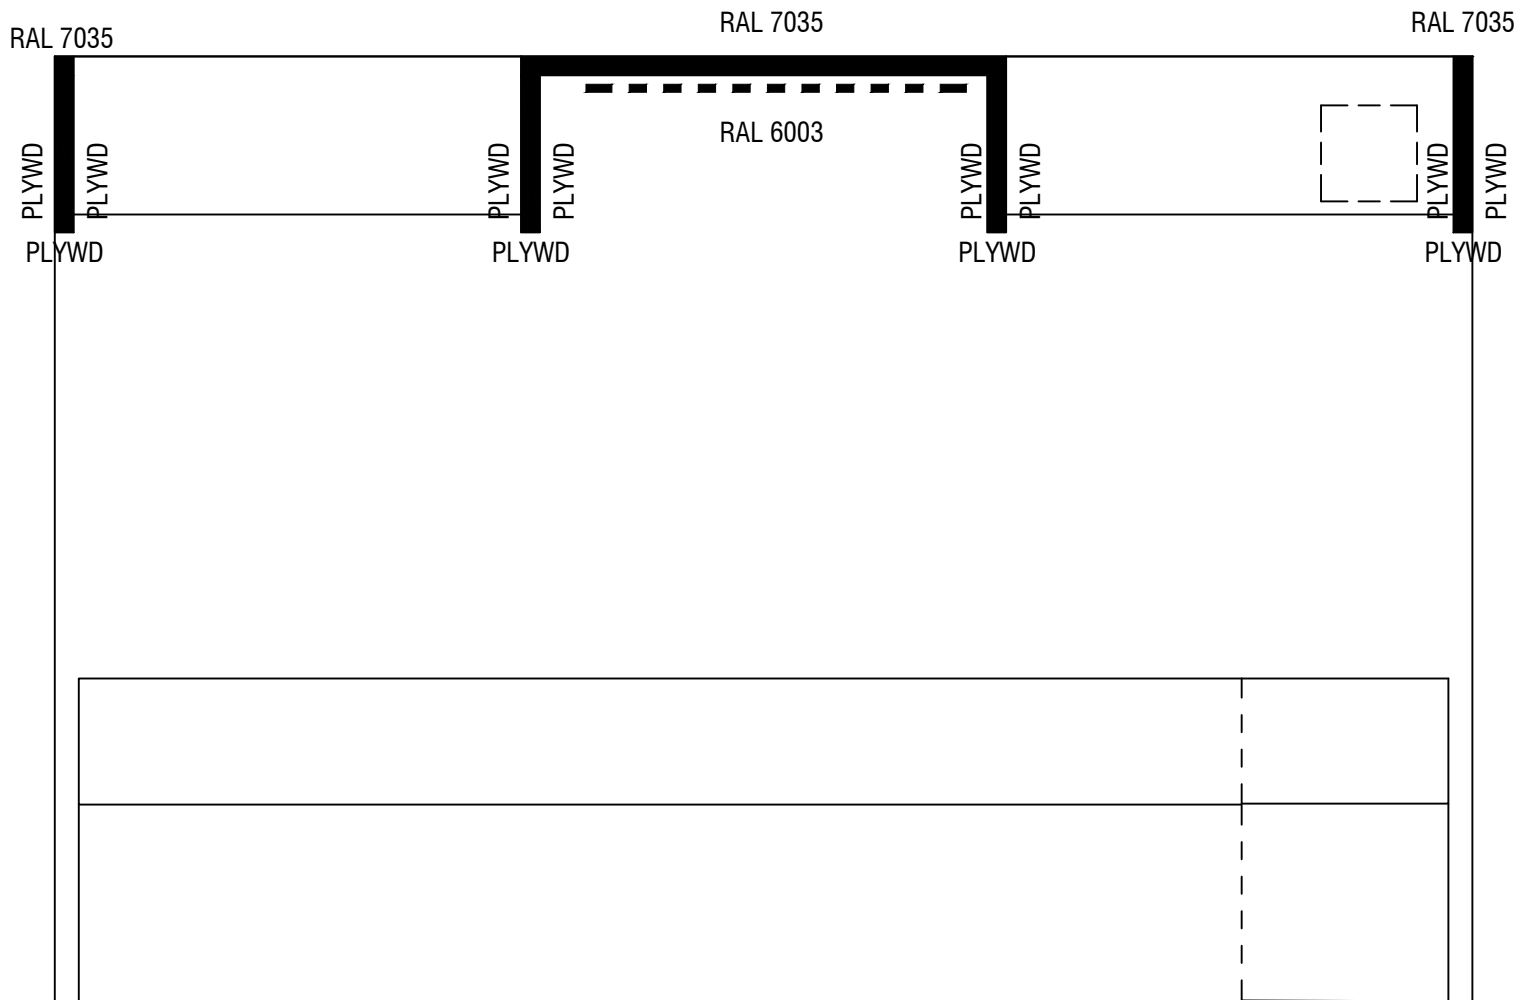

① PAINTING PLAN

SkLO



SkLO

95 WEST MATHESON STREET
HEALDSBURG CALIFORNIA 95448
CONTACT: PAUL PAVLAK
EMAIL: PAUL@SKLO.COM
TEL: 707.433.8797

STAND DESIGN
JAN 2019 MAISON&OBJET
-TENDER-

DATE ISSUED	09.27.2018
JOB NUMBER	-
FILENAME	-
SCALE	NOT TO SCALE

A3.0

PAINTING PLAN

SkLO



SkLO


95 WEST MATHESON STREET
HEALDSBURG CALIFORNIA 95448
CONTACT: PAUL PAVLAK
EMAIL: PAUL@SKLO.COM
TEL: 707.433.8797

STAND DESIGN
JAN 2019 MAISON&OBJET
-TENDER-

DATE ISSUED	09.27.2018
JOB NUMBER	-
FILENAME	-
SCALE	NOT TO SCALE

A3.1

PAINTING ELEVATION

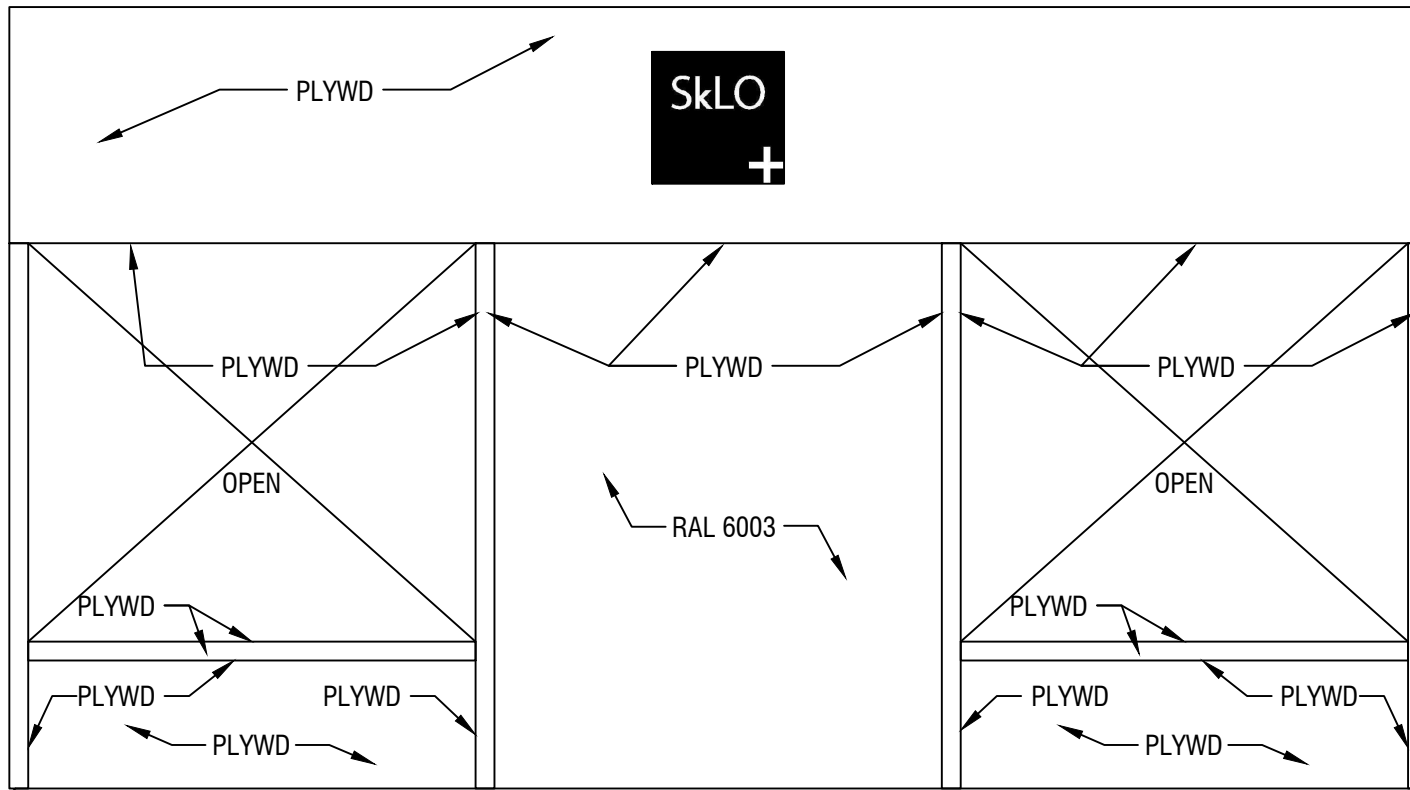

① PAINTING ELEVATION OF REAR WALL

SkLO



SkLO


95 WEST MATHESON STREET
HEALDSBURG CALIFORNIA 95448
CONTACT: PAUL PAVLAK
EMAIL: PAUL@SKLO.COM
TEL: 707.433.8797

STAND DESIGN
JAN 2019 MAISON&OBJET
-TENDER-

DATE ISSUED	09.27.2018
JOB NUMBER	-
FILENAME	-
SCALE	NOT TO SCALE

A3.2

PAINTING ELEVATION

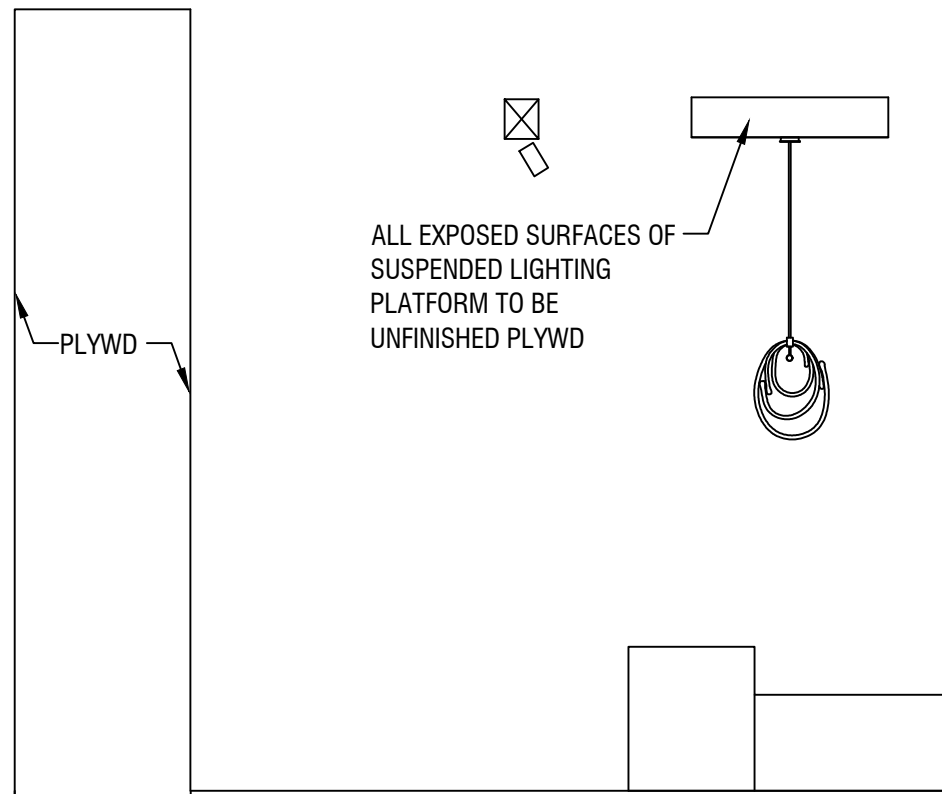

ALL EXPOSED SURFACES OF
SUSPENDED LIGHTING
PLATFORM TO BE
UNFINISHED PLYWD

PLYWD

① PAINTING ELEVATION - SIDE VIEW

SkLO



SkLO


95 WEST MATHESON STREET
HEALDSBURG CALIFORNIA 95448
CONTACT: PAUL PAVLAK
EMAIL: PAUL@SKLO.COM
TEL: 707.433.8797

STAND DESIGN
JAN 2019 MAISON&OBJET
-TENDER-

DATE ISSUED	09.27.2018
JOB NUMBER	-
FILENAME	-
SCALE	NOT TO SCALE

A3.3

PAINTING ELEVATION

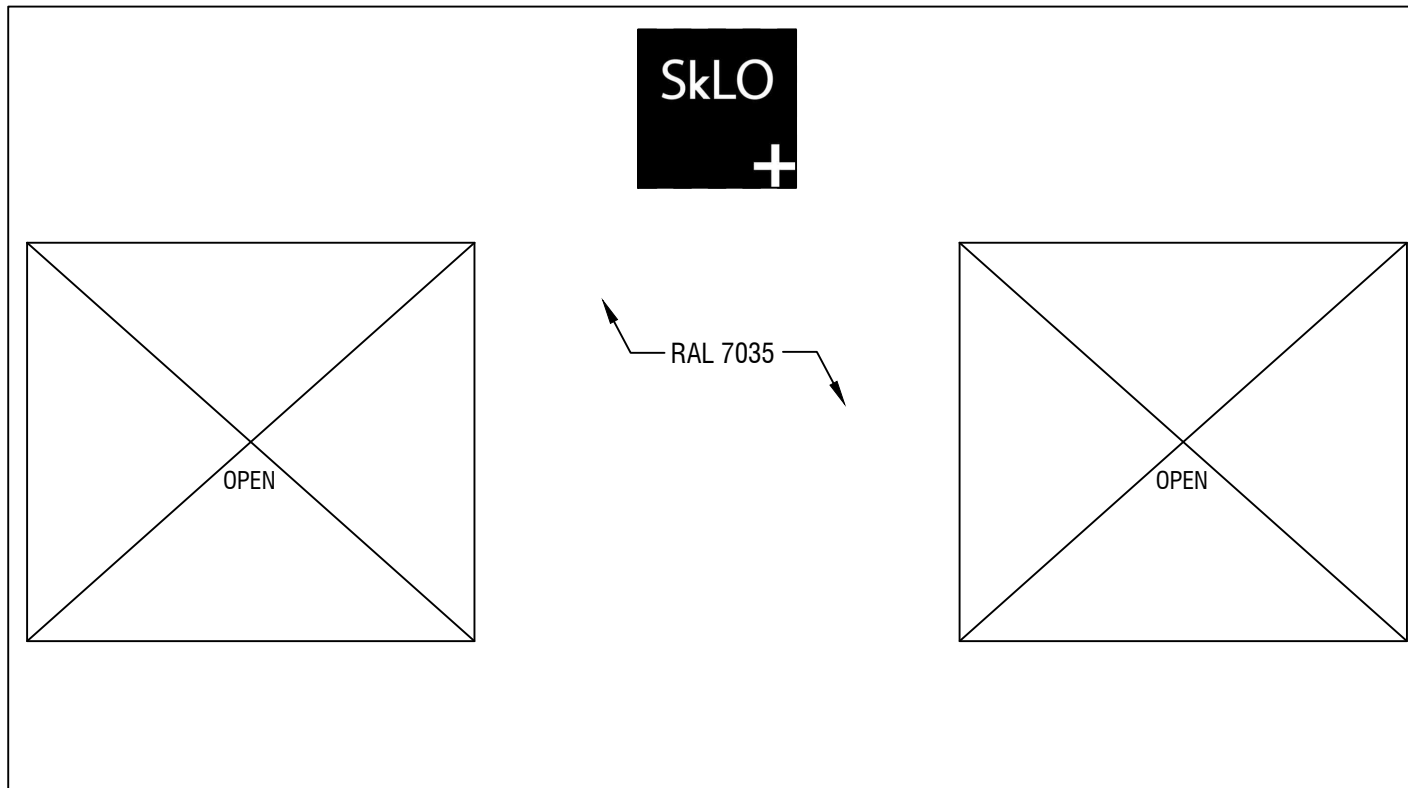

① PAINTING ELEVATION - REAR WALL BACKSIDE